

A02-66
SEP

Unit # 140 2006 6900XD Western Star MH
Serial # 5KKMACK76PV35946
License # G20135
Weight : Steering 14,680kg 445/65R22.5
 : Drives 14,680kg 385/95R25
Licenced Mass 53,600kg Tare 29,360kg
Engine DDC 60 – 515 HP #06R0872623
Trans : Main Eaton RTLO 16918B
 : Aux Spicer AT 1202
Rear Diff. Kessler D81DDPL477
 D81VPL477
 7.28 Ratio
Winch #1 Braden HP 125A serial #0600276
 #2 Braden HP 50 serial #0652399
Rig Up Marcep Mfg. Ltd.

T-T Bed Truck, 402" WB, 10'1" Wide
Hyd. - choke blocks 74" high @ roll
- kick bars
- ratchet kick roll
- flip 5th wheel (no gin poles)

Unit 140

Vin # V35946

Air Filter 2x

Donaldson P534816 or DBA5100

Wix 46843

Luberfiner LA4816

Engine Oil Filter 2x

Donaldson P552100

Wix 51971

Luberfiner LAP2160

Baldwin B495

Fram PH7405

Fleetgaurd LF3620

Fan Belt

DCO/17620 (3)

Alternator Belt

GT/4080562DF

Fuel Filters

Donaldson P550467

Luberfiner L5467F

Wix 33651XE

Fleetgaurd FS19624

Baldwin PF7748

Cab Filter

WWS/RD-3-877-0

Air Dryer Cartridge

R955T224N

Differential Filter

NA

Donaldson

Luberfiner

Wix

RONCO OILFIELD HAULING LTD.

Power Unit Lubrication Chart

Petro Canada Products

Engine Oil : Diesel - Duron E 15W40

Manual

Transmissions : Traxon Synthetic CD 50 *plus Power Up additive*

Allison

Automatic

Transmissions : Allison Transynd

Differentials : Traxon Synthetic 75W90 *plus Power Up additive*

Hydraulic oil : Hydrex MV22

Engine Coolant : Petro Canada 60-40

Winch

Planetary : Braden : Enduratex Synthetic EP 150

Tulsa : Traxon Synthetic 80W140

(refer to unit maintenance binder for winch type)

Grease : Precision Synthetic Moly


IF IN DOUBT - - - ASK!

ITEM	QTY	DESCRIPTION/MATERIALS	LENGTH	WEIGHT
0	-	-	-	-

TOTAL LBS: -

14.67m
581"

428 3/16"

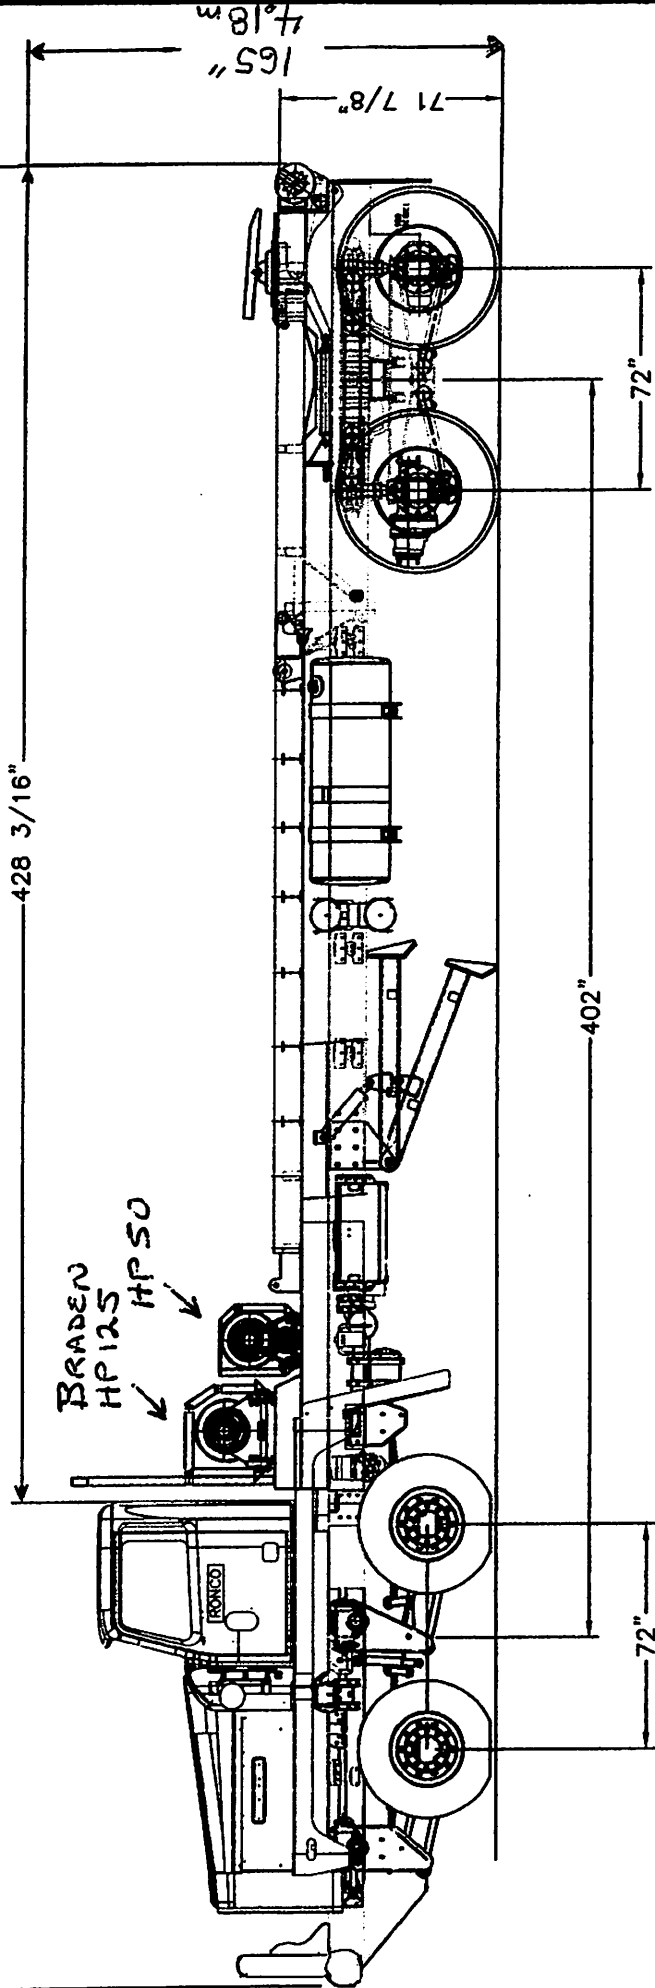

REFERENCE DRAWING NO. 3

MARCEP MFG LTD
4800 GOLF COURSE ROAD, STONY PLAIN, AB, T7Z 1W4, PH.(780) 988-4679
DESIGN and MANUFACTURING DIVISION

THIS DRAWING AND PARTS THEREOF REMAINS THE PROPERTY OF MARCEP LTD. IT MAY NOT BE REPRODUCED IN ANY FORM, BY ANY METHOD, FOR ANY PURPOSE WITHOUT THE EXPRESS WRITTEN CONSENT OF MARCEP LTD.

TITLE:	TRUCK LAYOUT	DWN BY:	C.C	DATE:	JAN/06
APPD:	-	DATE:	-	-	-
CUSTOMER:	RONCO	SCALE:	3/16"=1'-0"	CAD GENERATED DRAWING	NO MANUAL REVISION ALLOWED
W.O.#	2005-986	DWG NO.	RONCO-002	REV.	0

REV	DATE	DESCRIPTION	DRAWN	CHECKED	APPROVED
-	-	-	-	-	-